

K:\Projects\SA
 FILE: G-LONDONIA1-TEAT-FLT.dwg
 UPDATE BY: Murphy
 DATE: Thu 3/12/09 9:42am
 XREF DWG: ChInfo.dwg
 Ising
 IMAGE FILES:

REVISIONS	NUMBER	BY	DATE
	0		
	1		
	2		

THIS BAR IS EQUAL TO 2" AT FULL SCALE (4:225).


WASTEWATER TREATMENT PLANT
PROCESS FLOW DIAGRAM

GALESBURG SANITARY DISTRICT
GALESBURG, ILLINOIS

CMT
 CONSULTING ENGINEERS
 CLAMOR, MURPHY & TILLY, INC.
 License No. 184-00058

DESIGN BY: JED/CLC/RTB
 DRAWN BY: RDM
 CHECKED BY:
 APPROVED BY:
 DATE: FEBRUARY, 2003
 JOB No: 02089-02-02

SHEET OF SHEETS

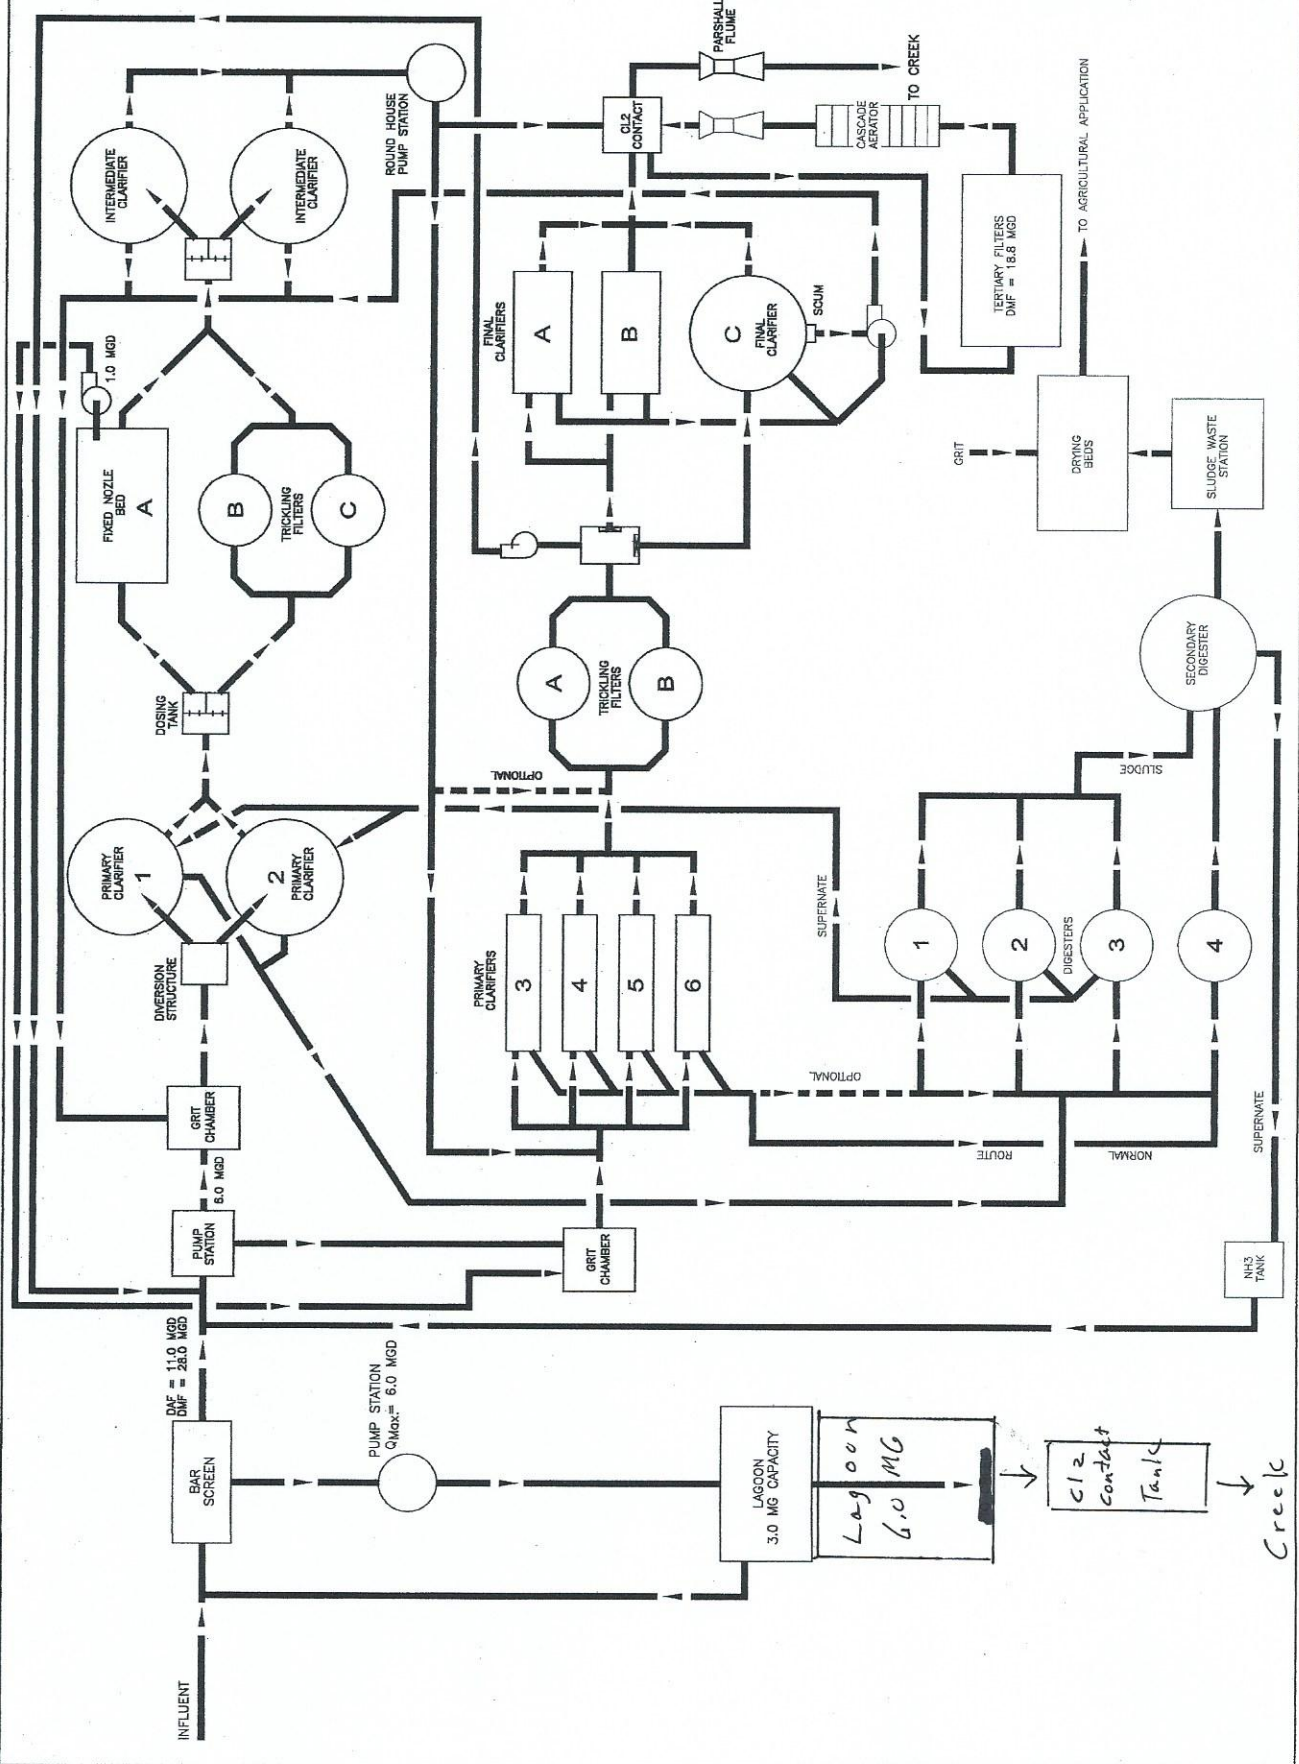

LAGOON
 3.0 MG CAPACITY
 Lagoon
 6.0 MG

CL2 Contact Tank

Creek